


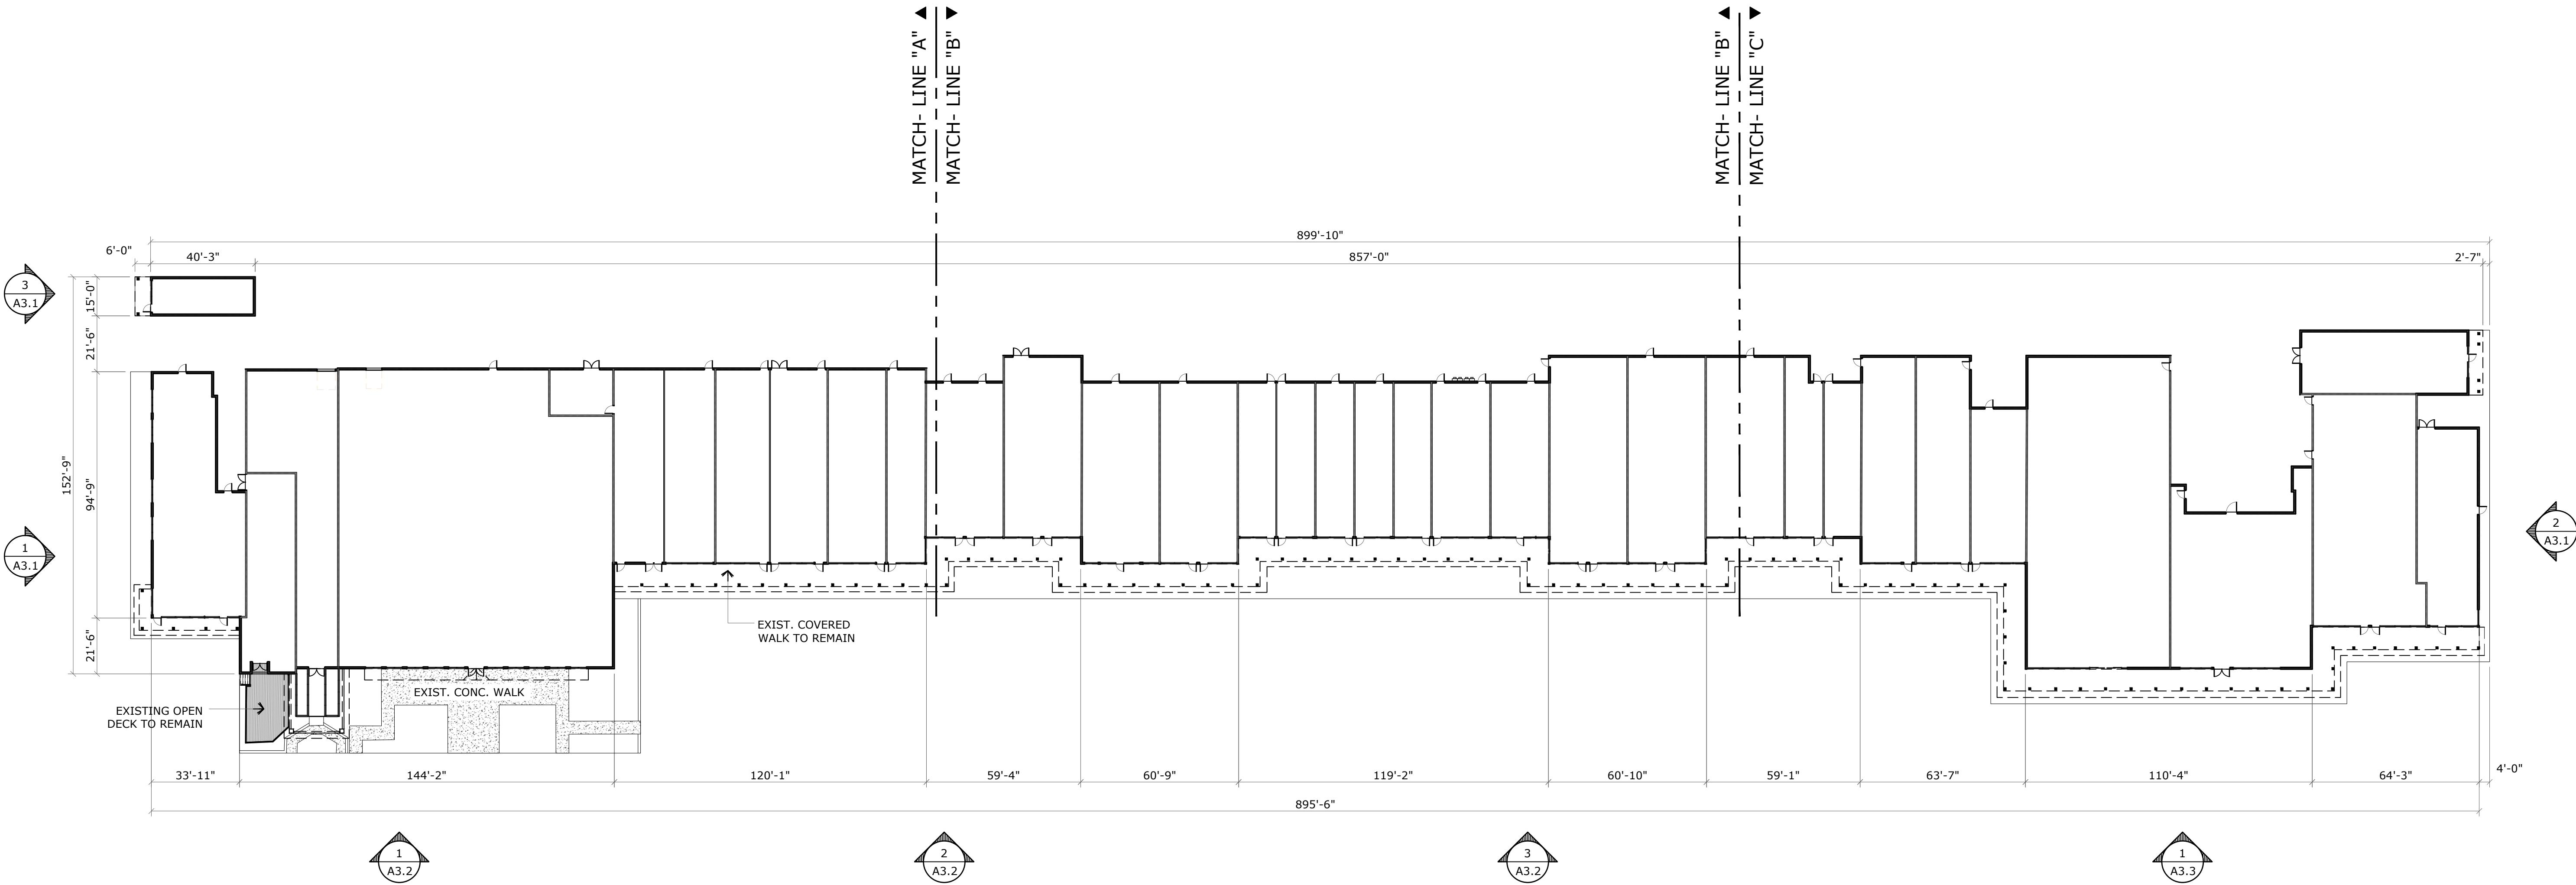



1 - EXISTING OVERALL FLOOR PLAN

SCALE: 1/32" = 1'-0"

WALL LEGEND

EXISTING EXT. CMU WALLS.

Commercial + Residential
2001 SE Ocean Blvd., Suite 300
Fort Lauderdale, FL 33316
Tel: (754) 220-4411
www.a2architect.com

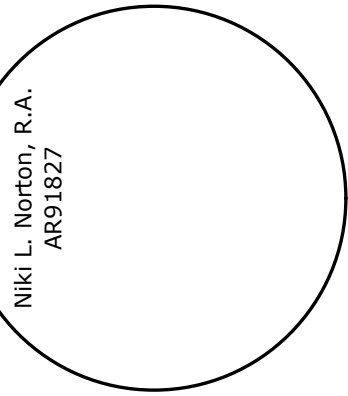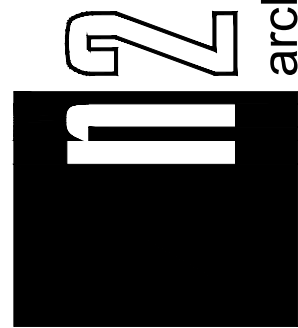


Village Square Shopping Center
221 S. U.S. Highway 1
Tequesta, FL 33469
Alex Redfearn, RCMRTV, LLC
(954) 553-7431

Rev. #	Date
Project Number	17-0348
Status	Site Plan Approval
Issue date	13-Jul-18
Sheet	A2.1
Overall Floor Plan	


Copyright ©

All drawings and written material appearing herein are the property of A2 Architecture + Design, LLC. No part of this drawing may be reproduced, stored in a retrieval system, or transmitted in any form or by any means, electronic, mechanical, photocopying, recording, or by any information storage and retrieval system, without the prior written consent of the Architect. A2 Architecture + Design, LLC is not responsible for any errors or omissions in this drawing.

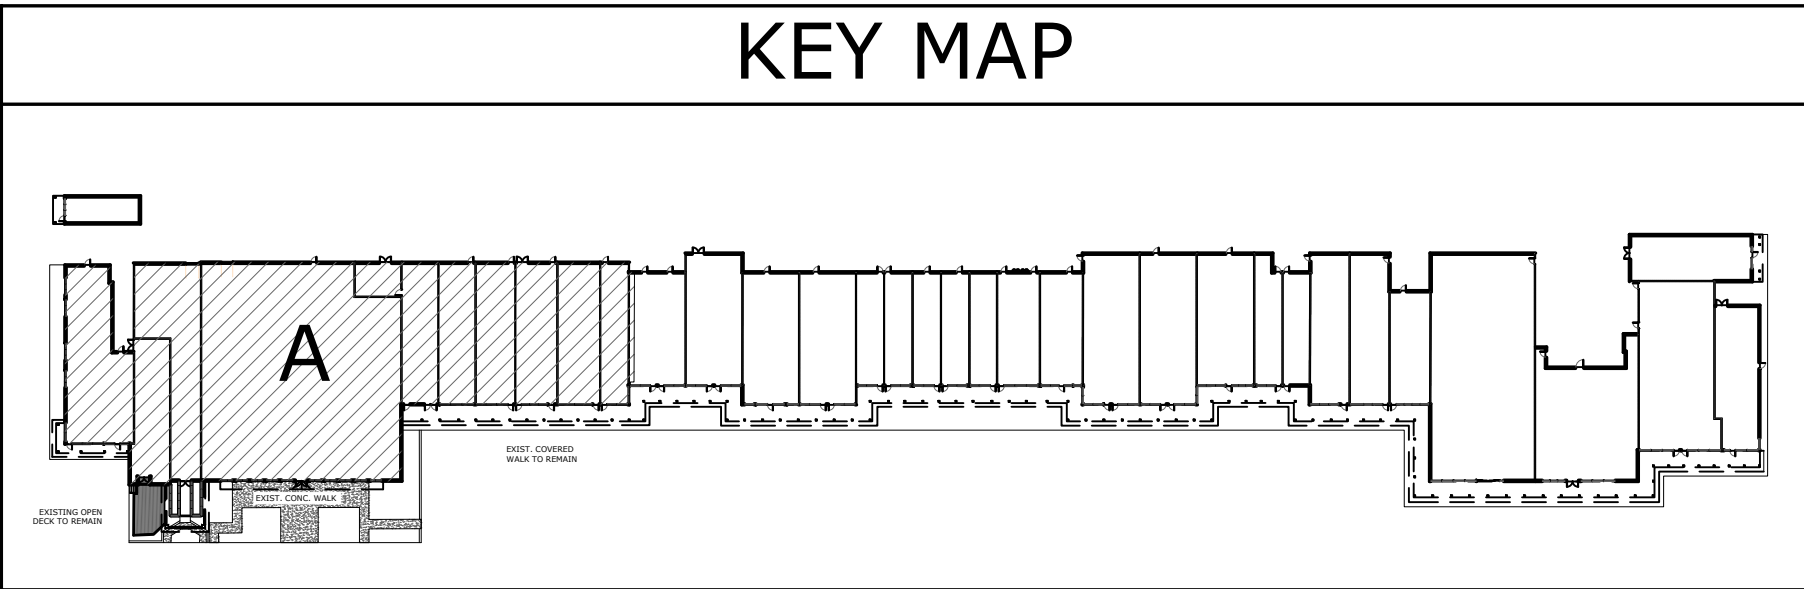

SCALE: 1/2" = 1'-0"

 SCALE: $3/32" = 1'-0"$



N


Floor Plan 'A'

All drawings and written material appearing herein constitute the original and unpublished work of the Architect, and the same or any part thereof may not be duplicated, distributed, disclosed, or used in any manner without the written consent of the Architect. Penalties shall apply when user duplicates Architect's work, without Architect's written consent.



architecture + design


Floor Plan 'B'

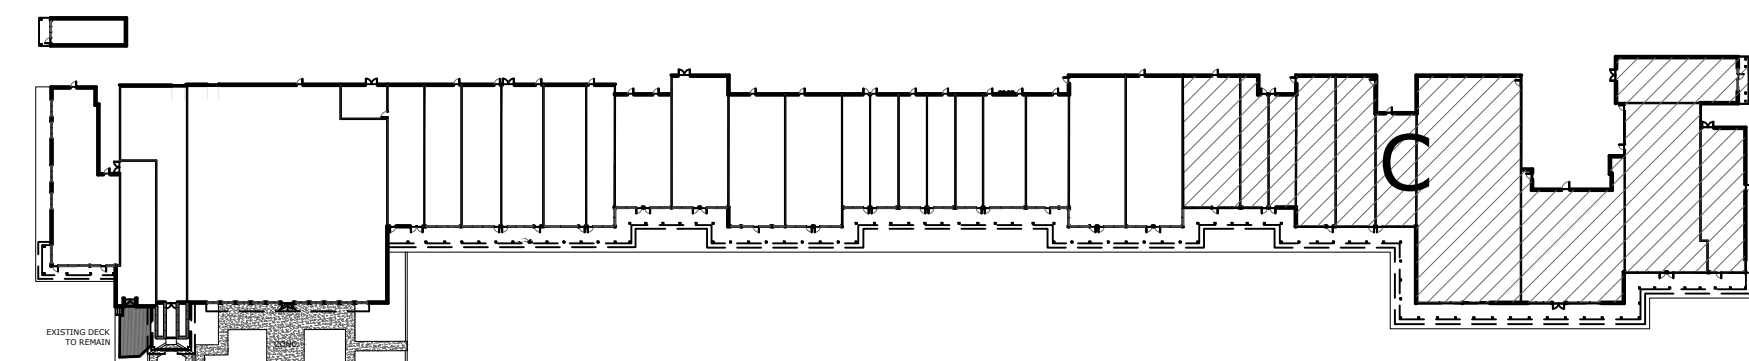

Commercial + Residential
2081 SE Ocean Blvd. Suite 1A
Stuart, FL 34996
O: (772) 220-4411
www.n2archdesign.com

Commercial + Residential
1100 E Ocean Blvd. Suite 1A
Stuart, FL 34996
O: (772) 220-4411
www.n2archdesign.com


2
Commercial + Residential
2081 SE Ocean Blvd.
Suite 200
O: (772) 339-2222
www.n2arch.com
architecture + design

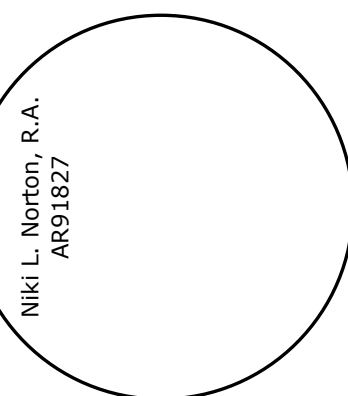


Village Square Shopping Center
221 S. U.S. Highway 1
Tequesta, FL 33469
Alex Redfearn, RCMRJV, LLC
(954) 553-7431

Rev. #	Date
Project Number	17-0348
Status	Site Plan Approval
Issue date	13-Jul-18
Sheet	A3.1c

 
Floor Plan 'C'

X COLOR SCHEDULE		
Sherwin-Williams Color Palate		
COLOR	MARK	DESCRIPTION
	1	COLOR: SW 7005 - "PURE WHITE"
	2	COLOR: SW 7665 - "WALL STREET"
	3	COLOR: SW 7615 - "SEA SERPENT"
GENERAL NOTES		
1. Refer to official exterior color palette samples from the manufacturer. They are shown herein for purely representational purposes only.		
2. Prep surfaces before application according to paint supplier recommendations.		


GENERAL NOTES	
1. See Exterior Elevations for selected color.	
2. Refer to Wall Sections & Roof Plans for more information.	

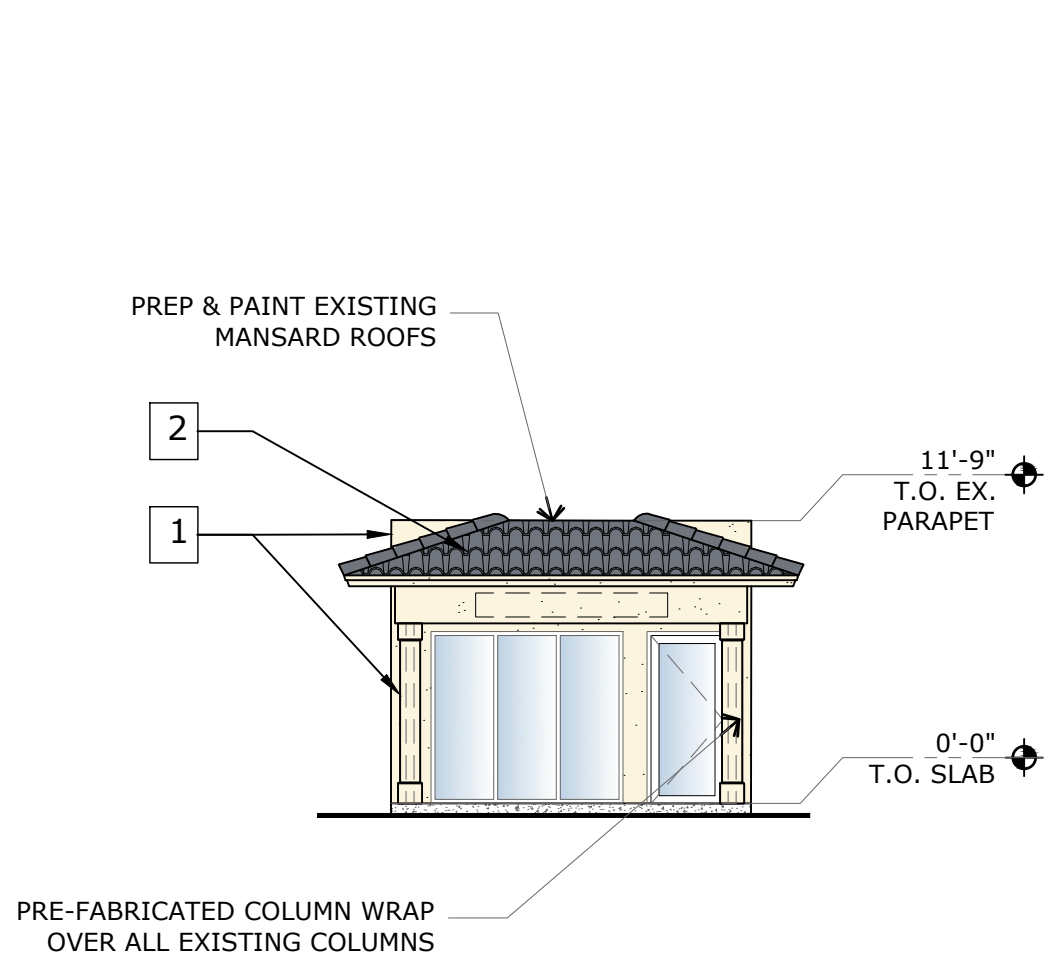


3 - NORTH OUTPARCEL ELEVATION
SCALE: 1/8" = 1'-0"

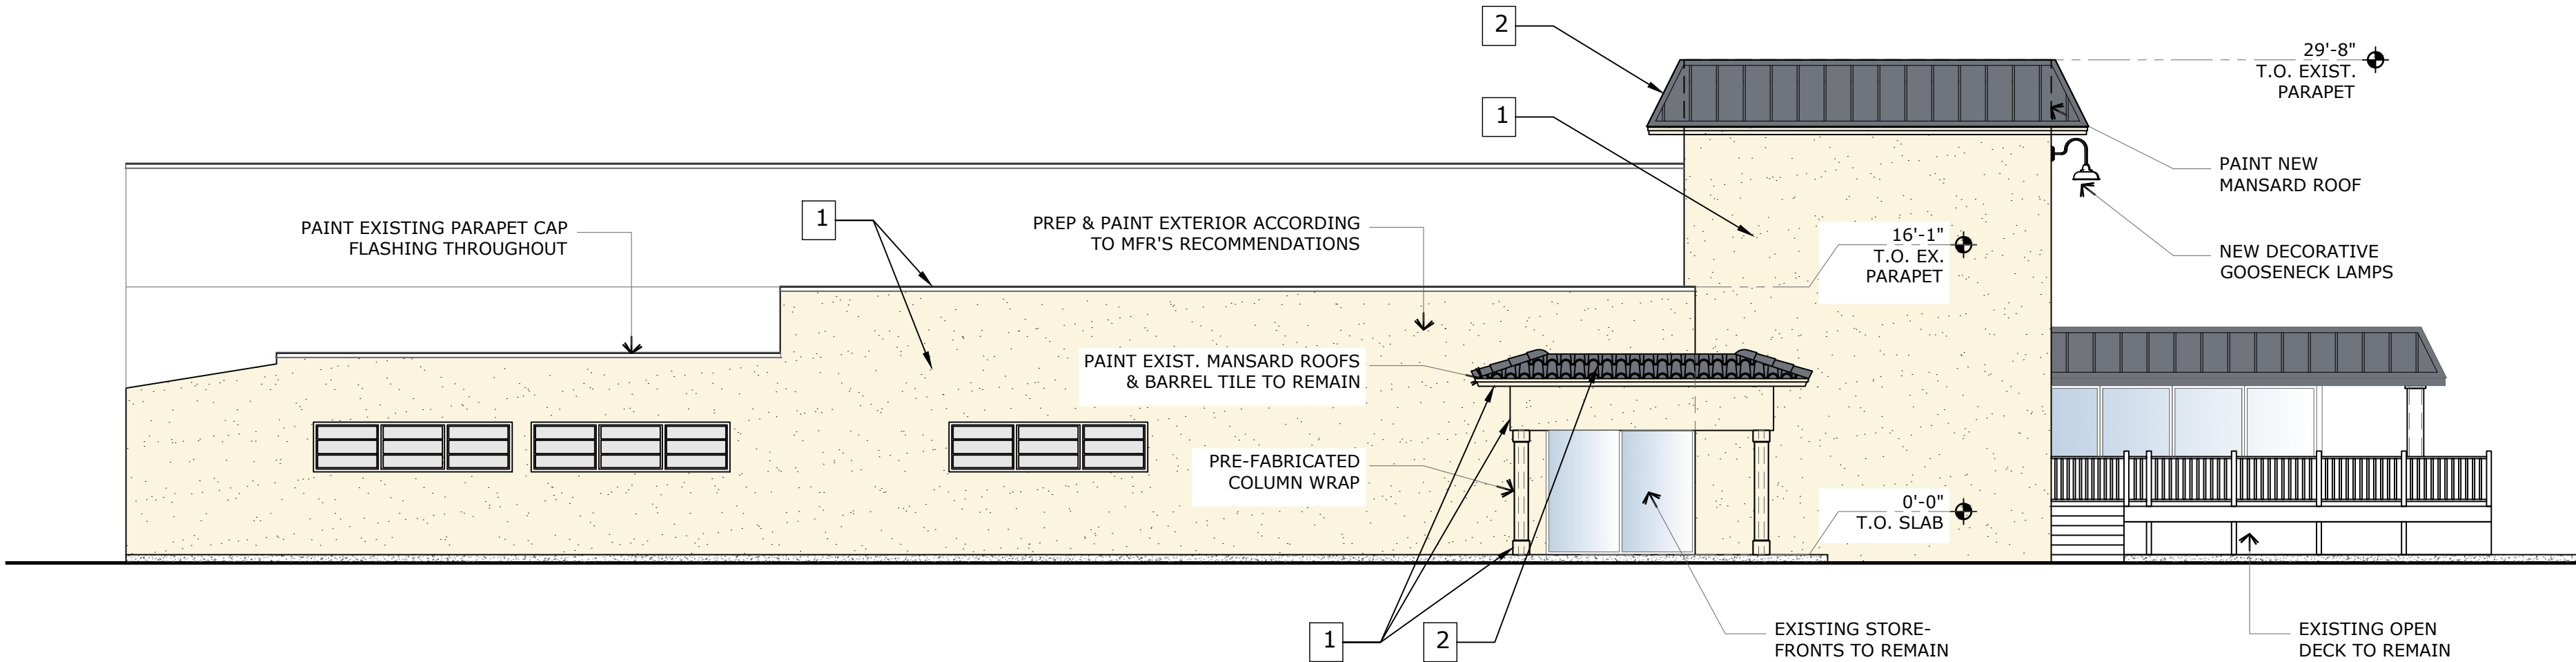

1 - NORTH ELEVATION
SCALE: 1/8" = 1'-0"

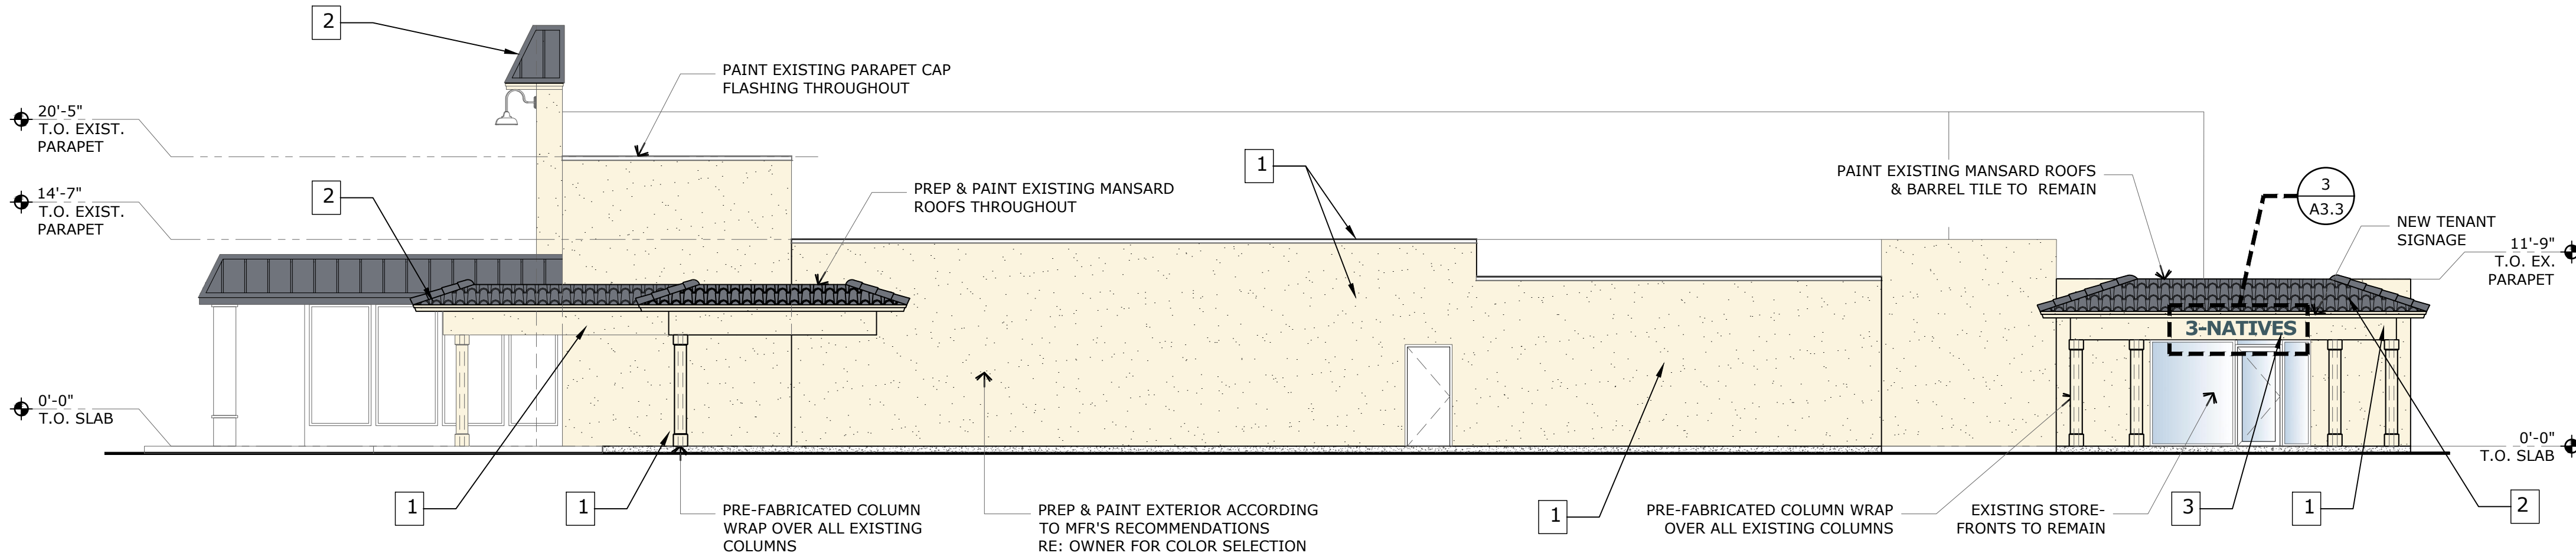

2 - SOUTH ELEVATION
SCALE: 1/8" = 1'-0"

 X SCHEDULE Sherwin-Williams Color Palette		
COLOR	MARK	DESCRIPTION
	1	COLOR: SW 7005 - "PURE WHITE"
	2	COLOR: SW 7665 - "WALL STREET"
	3	COLOR: SW 7615 - "SEA SERPENT"

 
GENERAL NOTES

- Refer to official exterior color palette samples from the manufacturer. They are shown herein for purely representational purposes only.
- Prep surfaces before application according to paint supplier recommendations.


SCALE: 1/8" = 1'-0"




SCALE: NTS




SCALE: NTS

 

SCALE: NTS

 


SCALE: NTS

 

SCALE: NTS


LIGHTING SCHEDULE						
TYPE	MANUFACTURER/ MODEL NUMBER	DESCRIPTION	LAMP	VOLTS	NOTES:	OR EQUAL MANUFACTURER
A	BASELITE Corporation WS20-44/E4A-44/LED	Wet-Listed Gooseneck Lighting Fixture With Arm Extension	79 Watts	120	-	-
B	JUNO Lighting Group JSF 71W D9LM 40K 90CRI MVOLT ZT WH	Wet-Listed Surface-Mounted Downlight LED Light Fixture	13 Watts	120	-	-
LIGHTING SCHEDULE GENERAL NOTES:						
1. All light fixtures shall be selected by Owner and installed by GC. 2. Install light fixtures as per manufacturer specifications. 3. Provide new bulbs for all new installed light fixtures. 4. Fixture finishes shall be selected by Owner. 5. Coordinate final location of fixtures with Owner prior to installation.						

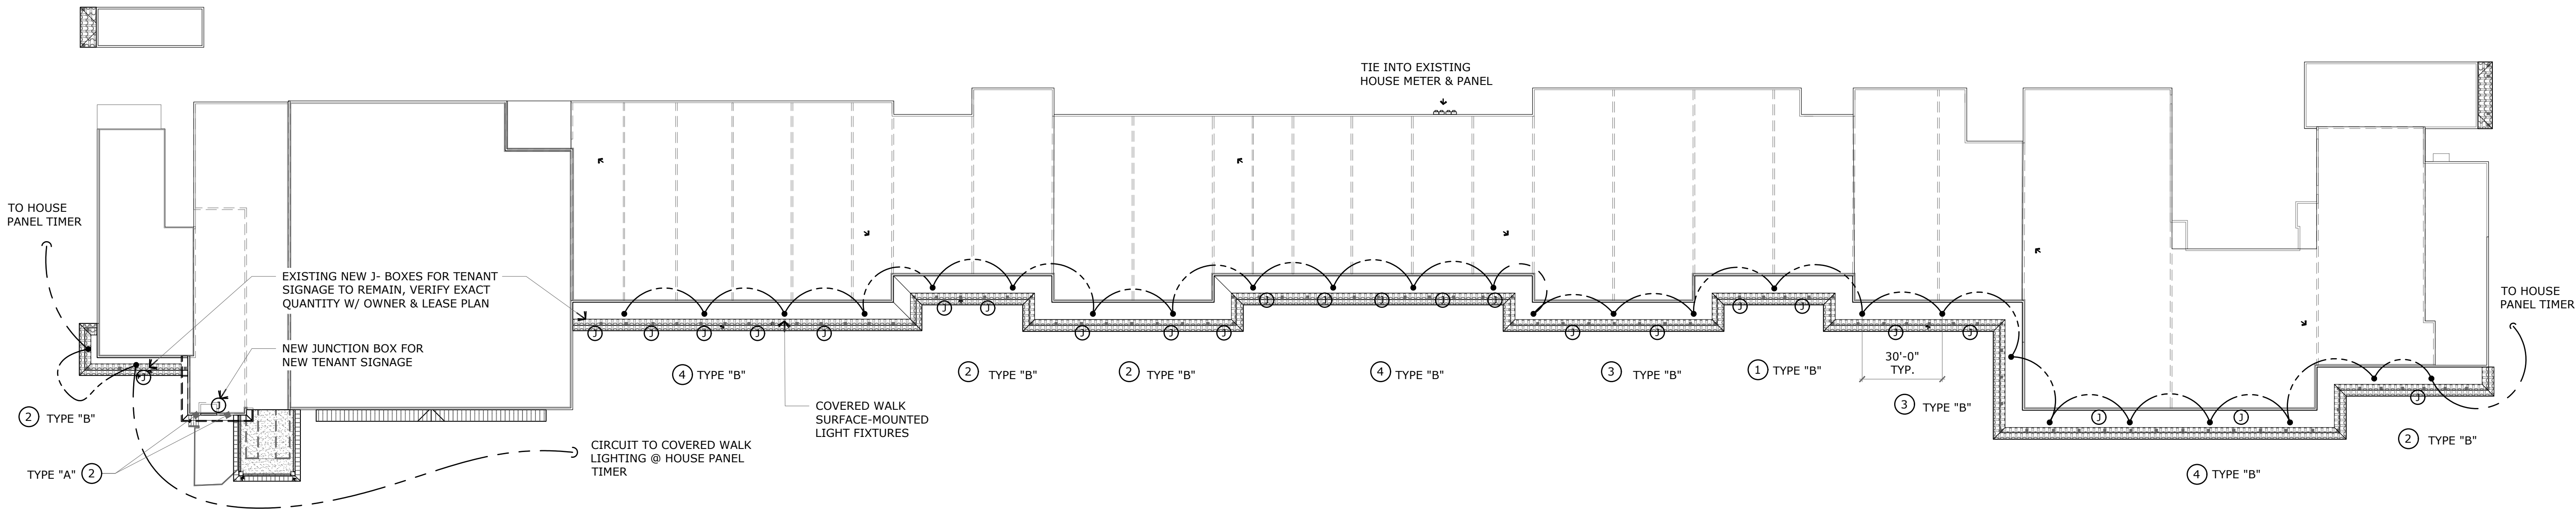


1 - COVERED WALK LIGHTING PLAN

SCALE: 1/32" = 1'-0"

Commercial + Residential
2001 SE Ocean Blvd., Suite 300
Ocala, FL 34901
Tel: (352) 220-4411
www.a2archdesign.com

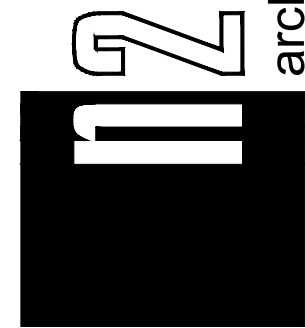

architecture + design

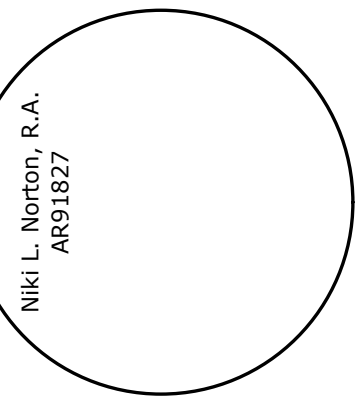

Village Square Shopping Center

221 S. U.S. Highway 1
Tequesta, FL 33469
Alex Redfearn, RCMRJV, LLC
(954) 553-7431

Rev. #	Date
Project Number	17-0348
Status	Site Plan Approval
Issue date	13-Jul-18
Sheet	E2.0

Rooftop
Lighting Plan